

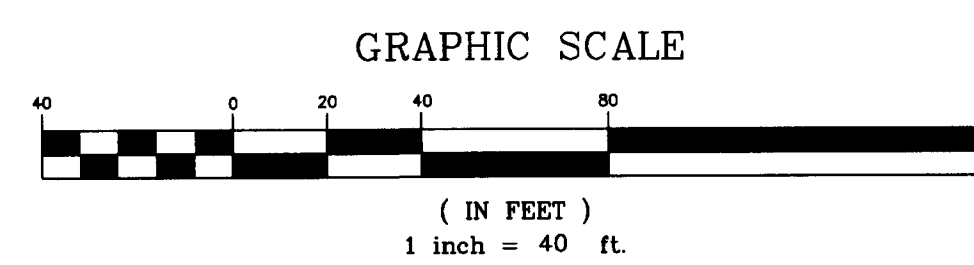
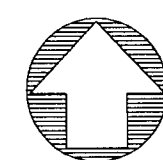


THIS TECHNICAL DATA PLAN (1-20-06) WILL  
REPLACE THE PREVIOUSLY SUBMITTED  
SCHEMATIC SITE PLAN (12-07-05)

( IN FEET )  
1 inch = 50 ft.

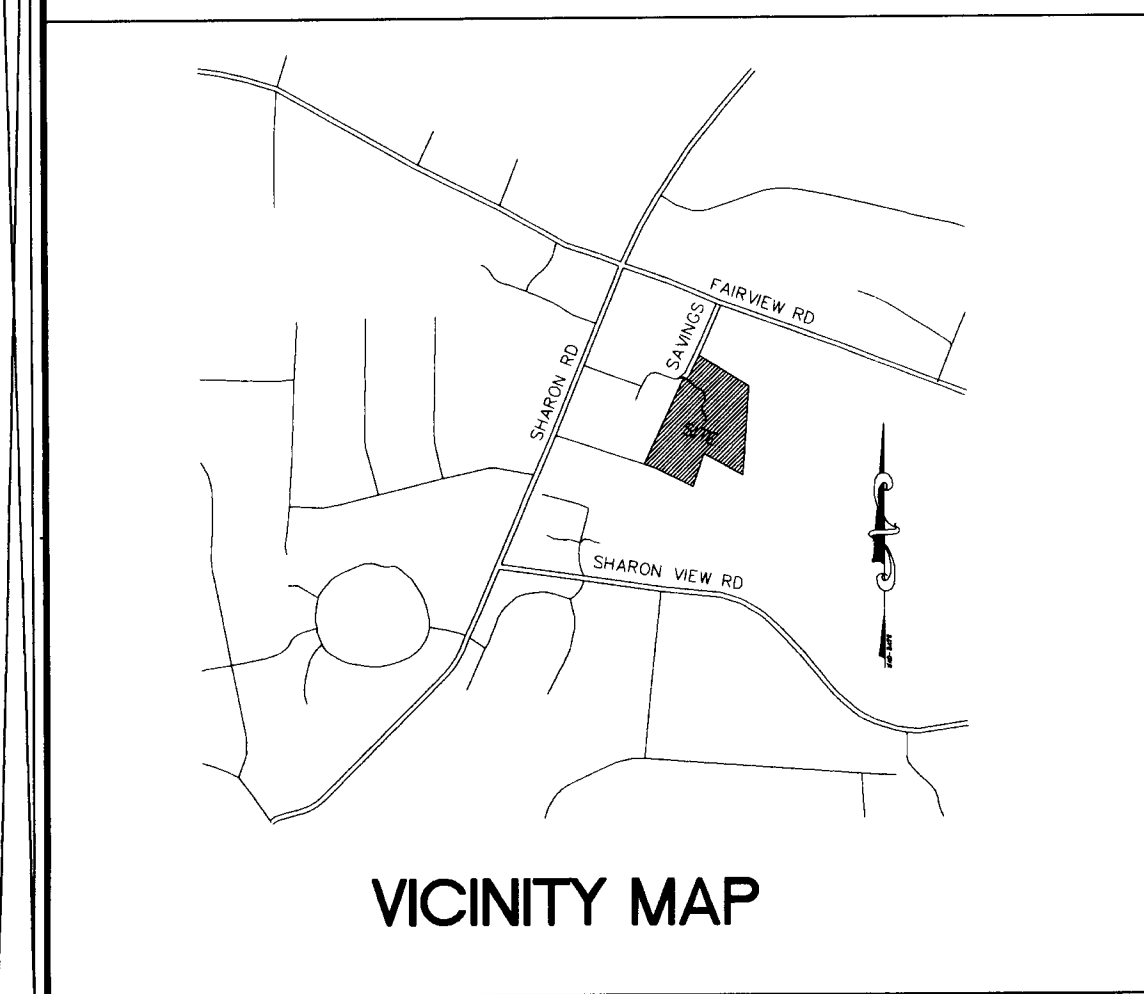

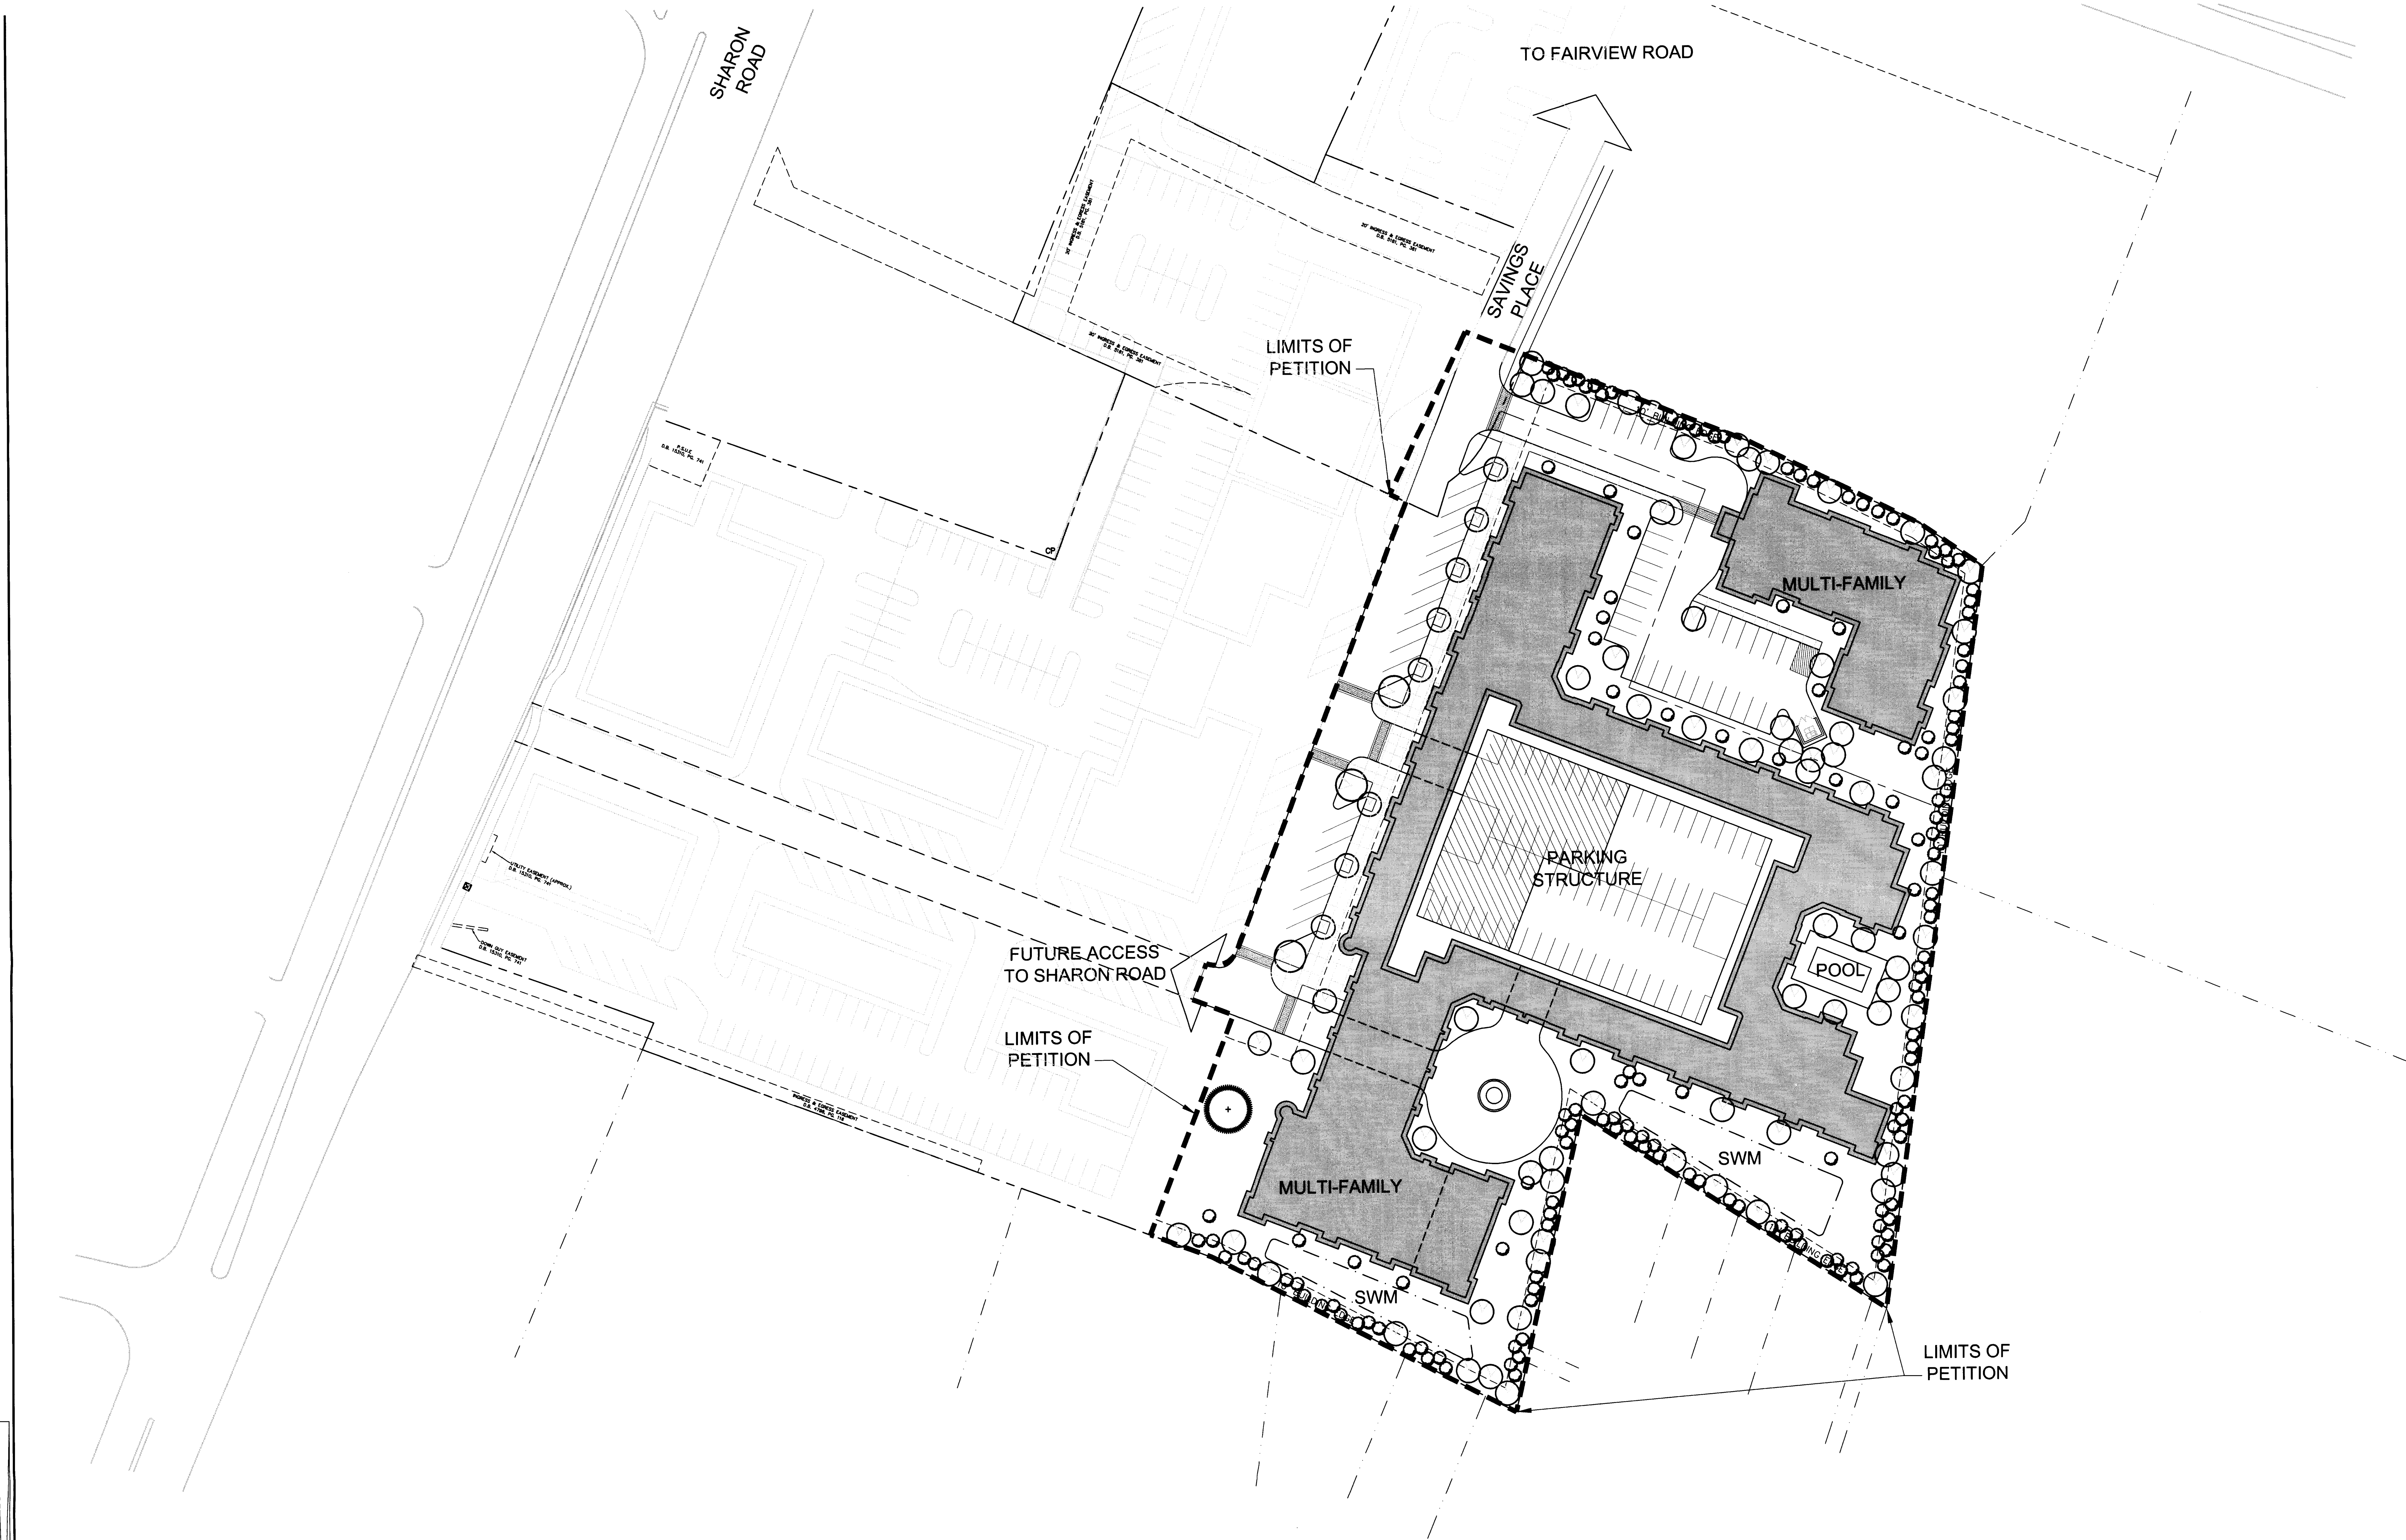

**NOTE:**  
THIS SCHEMATIC SITE PLAN (1-20-06) WILL REPLACE THE PREVIOUSLY SUBMITTED SCHEMATIC SITE PLAN (12-07-05)

**NOTE:**  
THIS PLAN IS FOR ILLUSTRATIVE PURPOSES ONLY AND DEPICTS A POSSIBLE DEVELOPMENT SCHEME. FINAL LAYOUT WILL BE DETERMINED DURING DESIGN DEVELOPMENT AND CONSTRUCTION DOCUMENT PREPARATION.

**PROJECT NAME**  
Live Oaks Property Rezoning

**PROJECT TEAM**  
PRINCIPAL IN CHARGE:  
J. Gamble, ASLA  
PROJECT MANAGER:  
C. Chastain, RLA  
DRAWN BY:  
C. Chastain, RLA

**REVISIONS**

NO.	REVISION	DATE
1	Recommittal Revision	1/20/06


**SHEET TITLE**  
Schematic Site Plan

**PROJECT NO.**  
101.1686.00  
**ISSUE DATE**  
12/07/05  
**SHEET NUMBER**  
RZ-2







**SECTION "A"**  
**1"=10'**

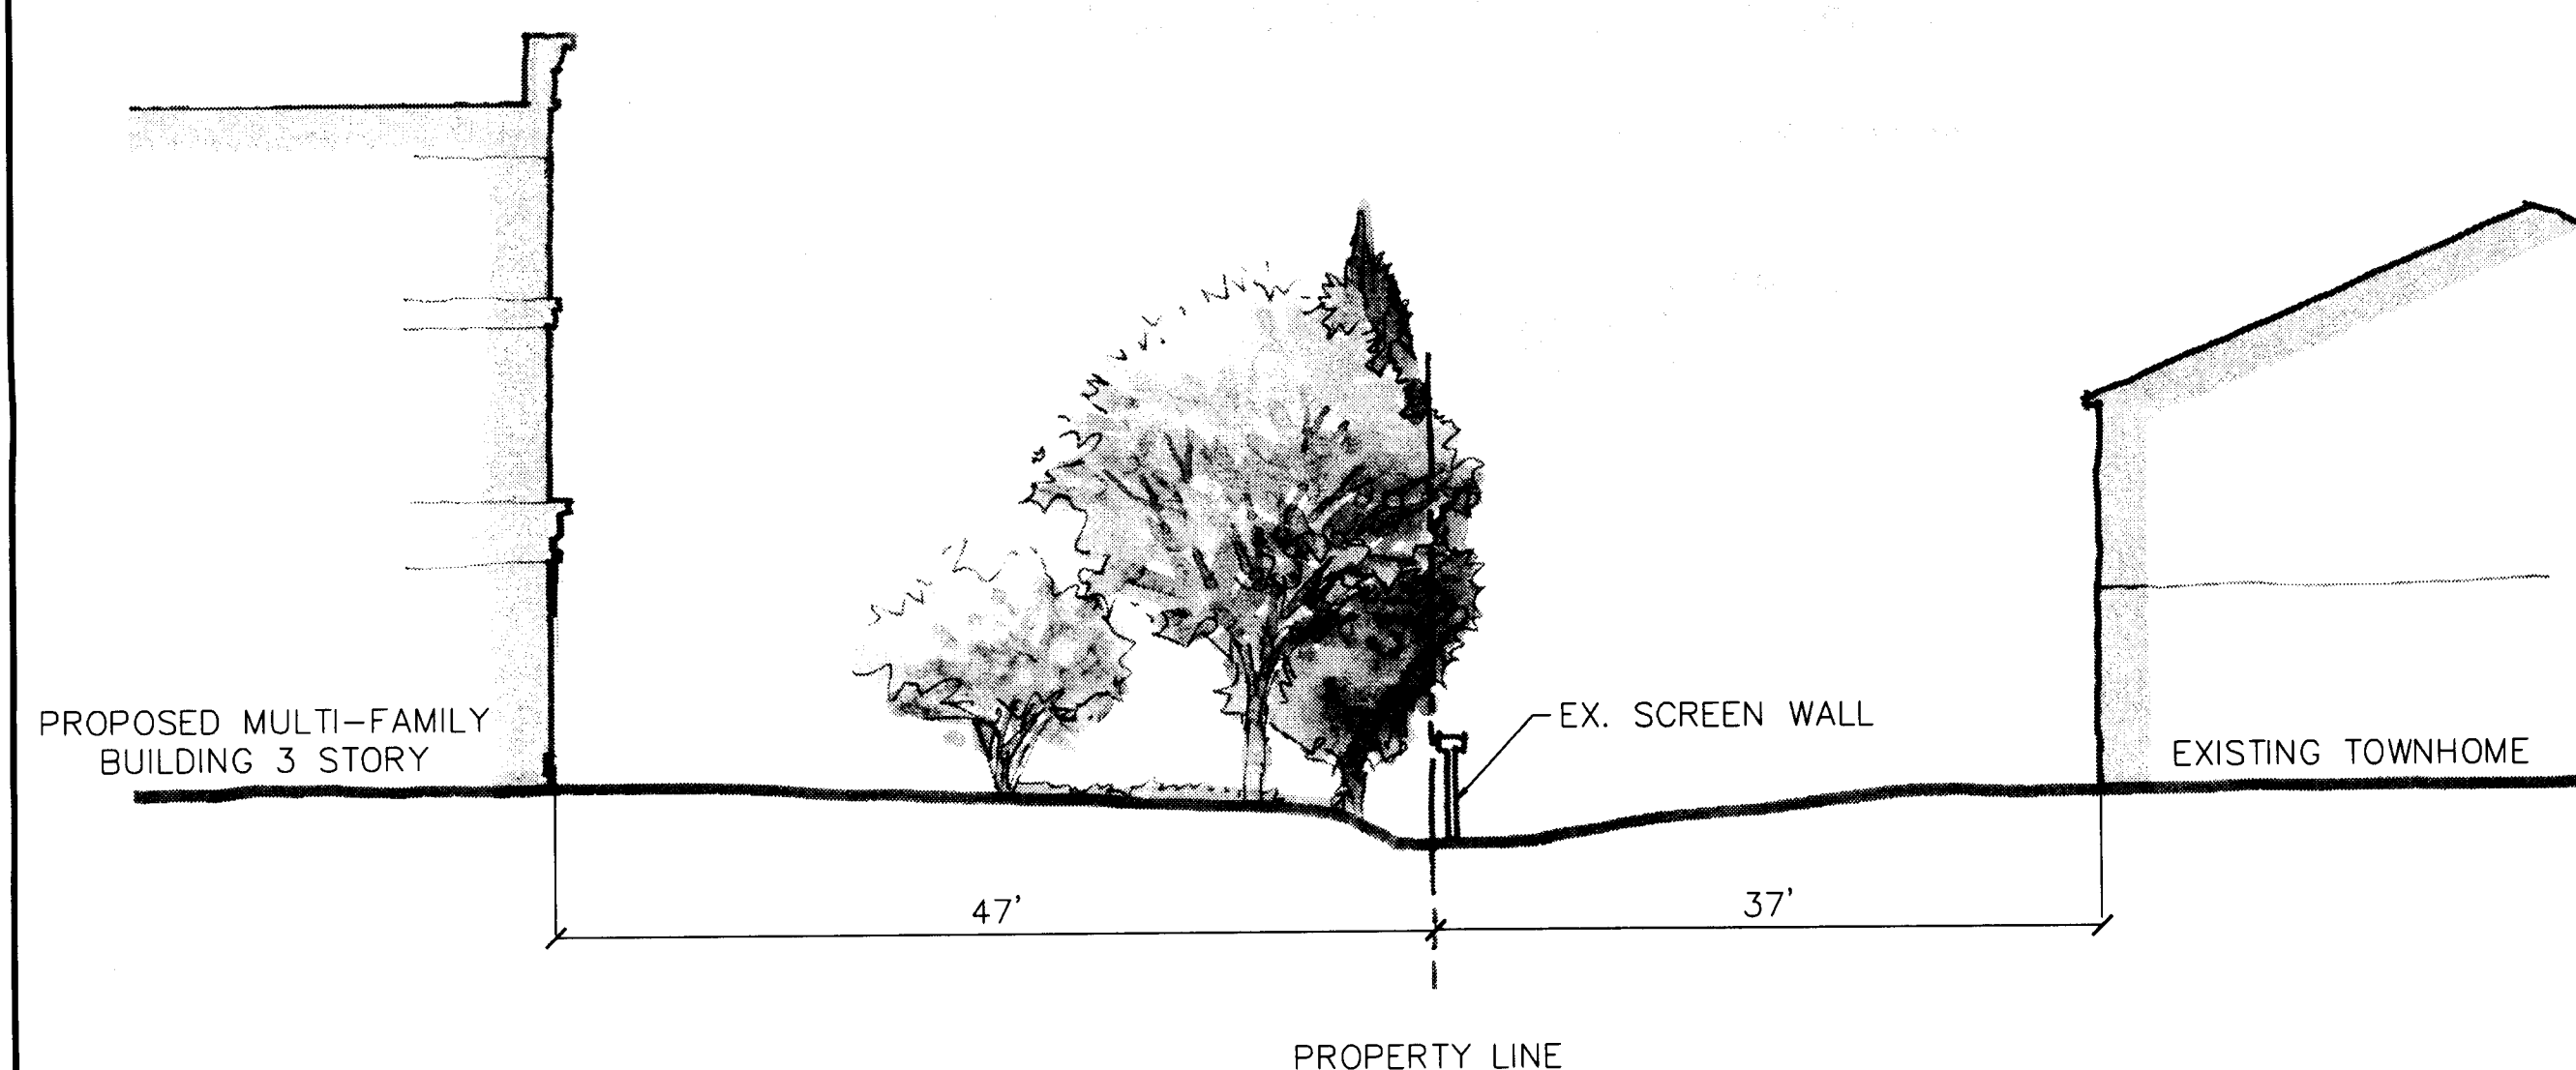


**SECTION "B"**  
**1"=10'**

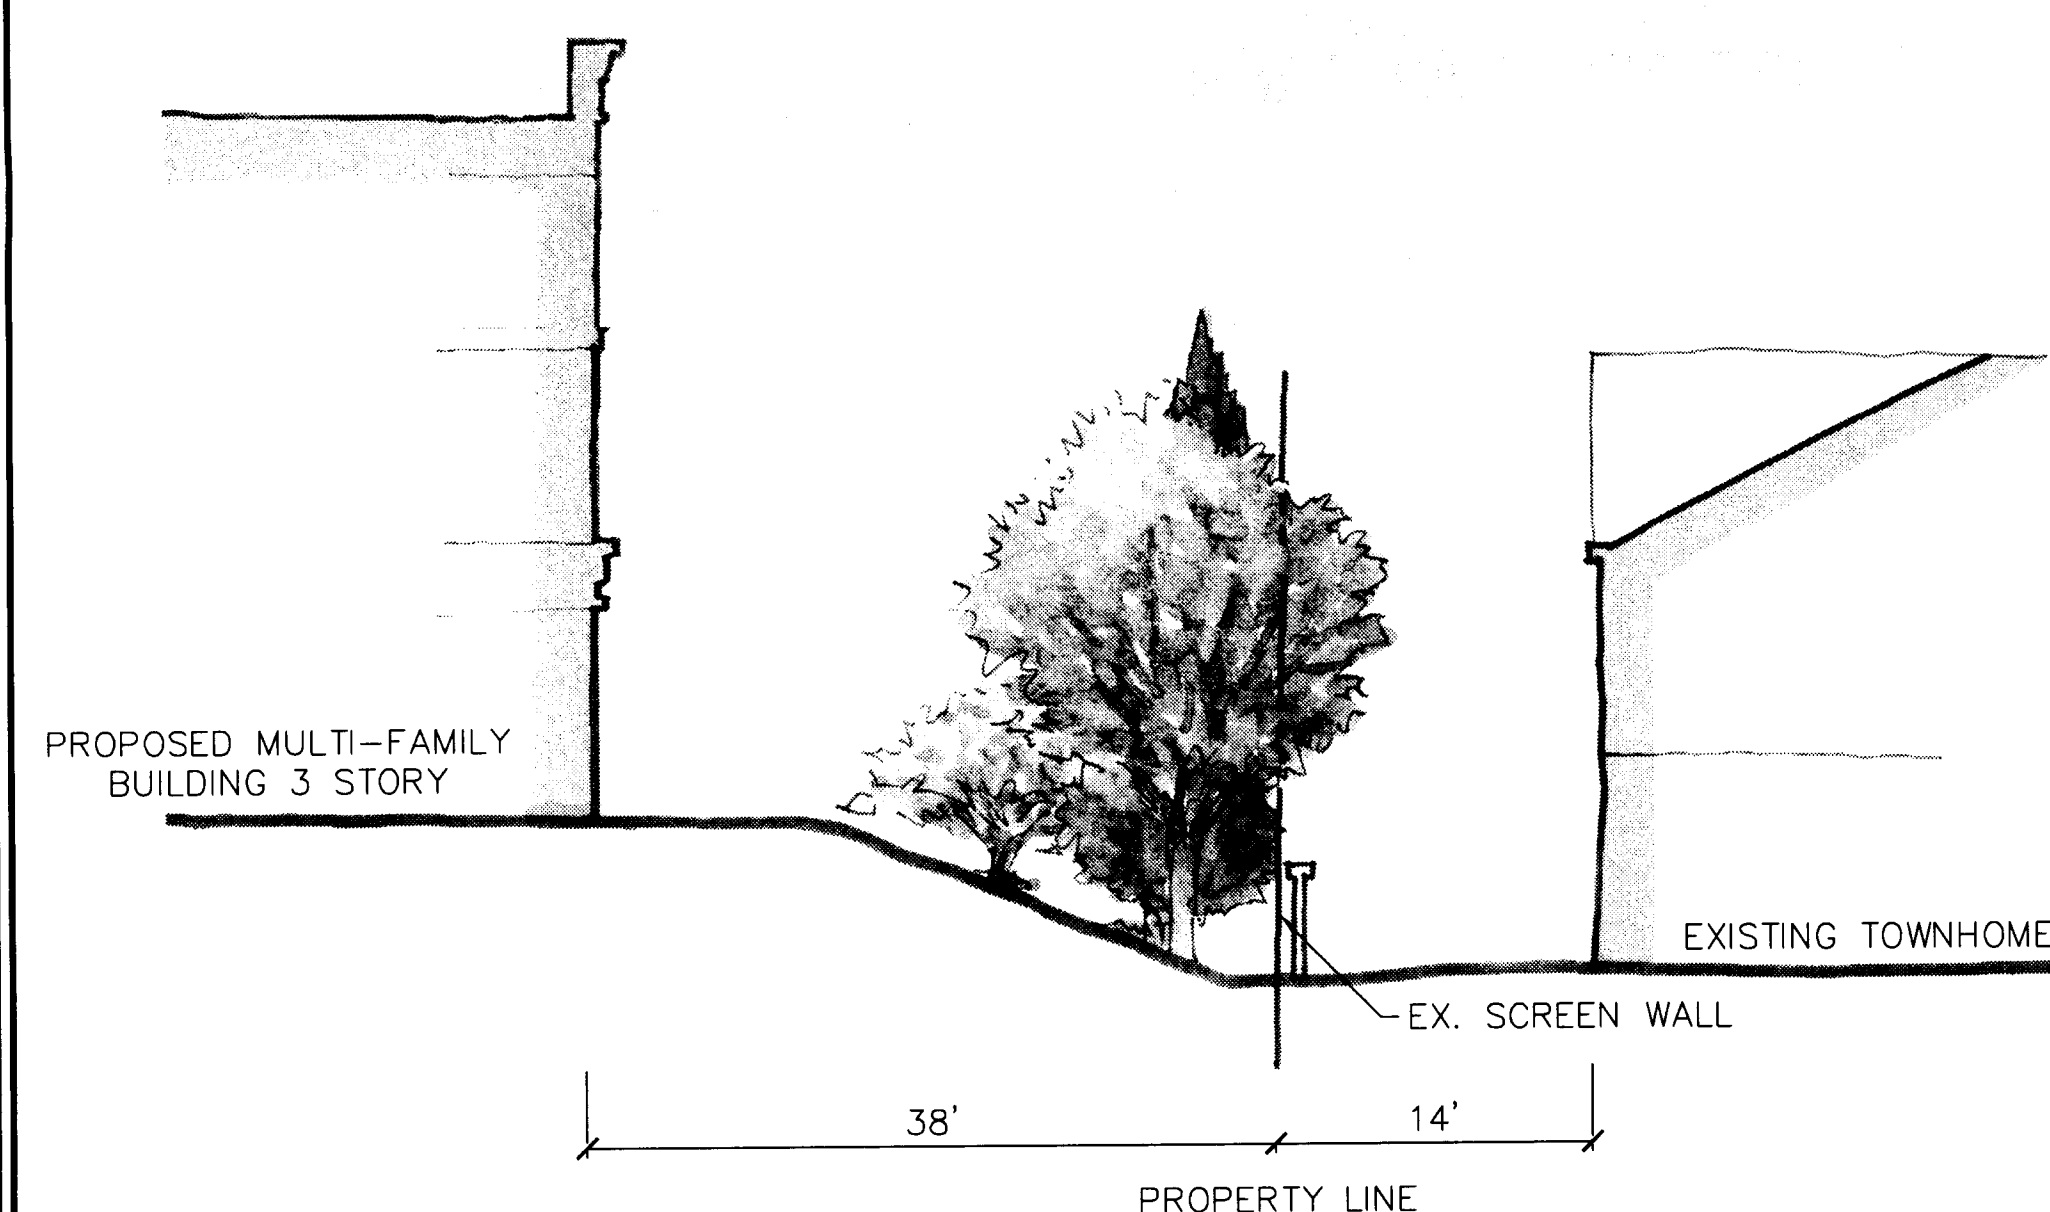


**SECTION "C"**  
**1"=10'**

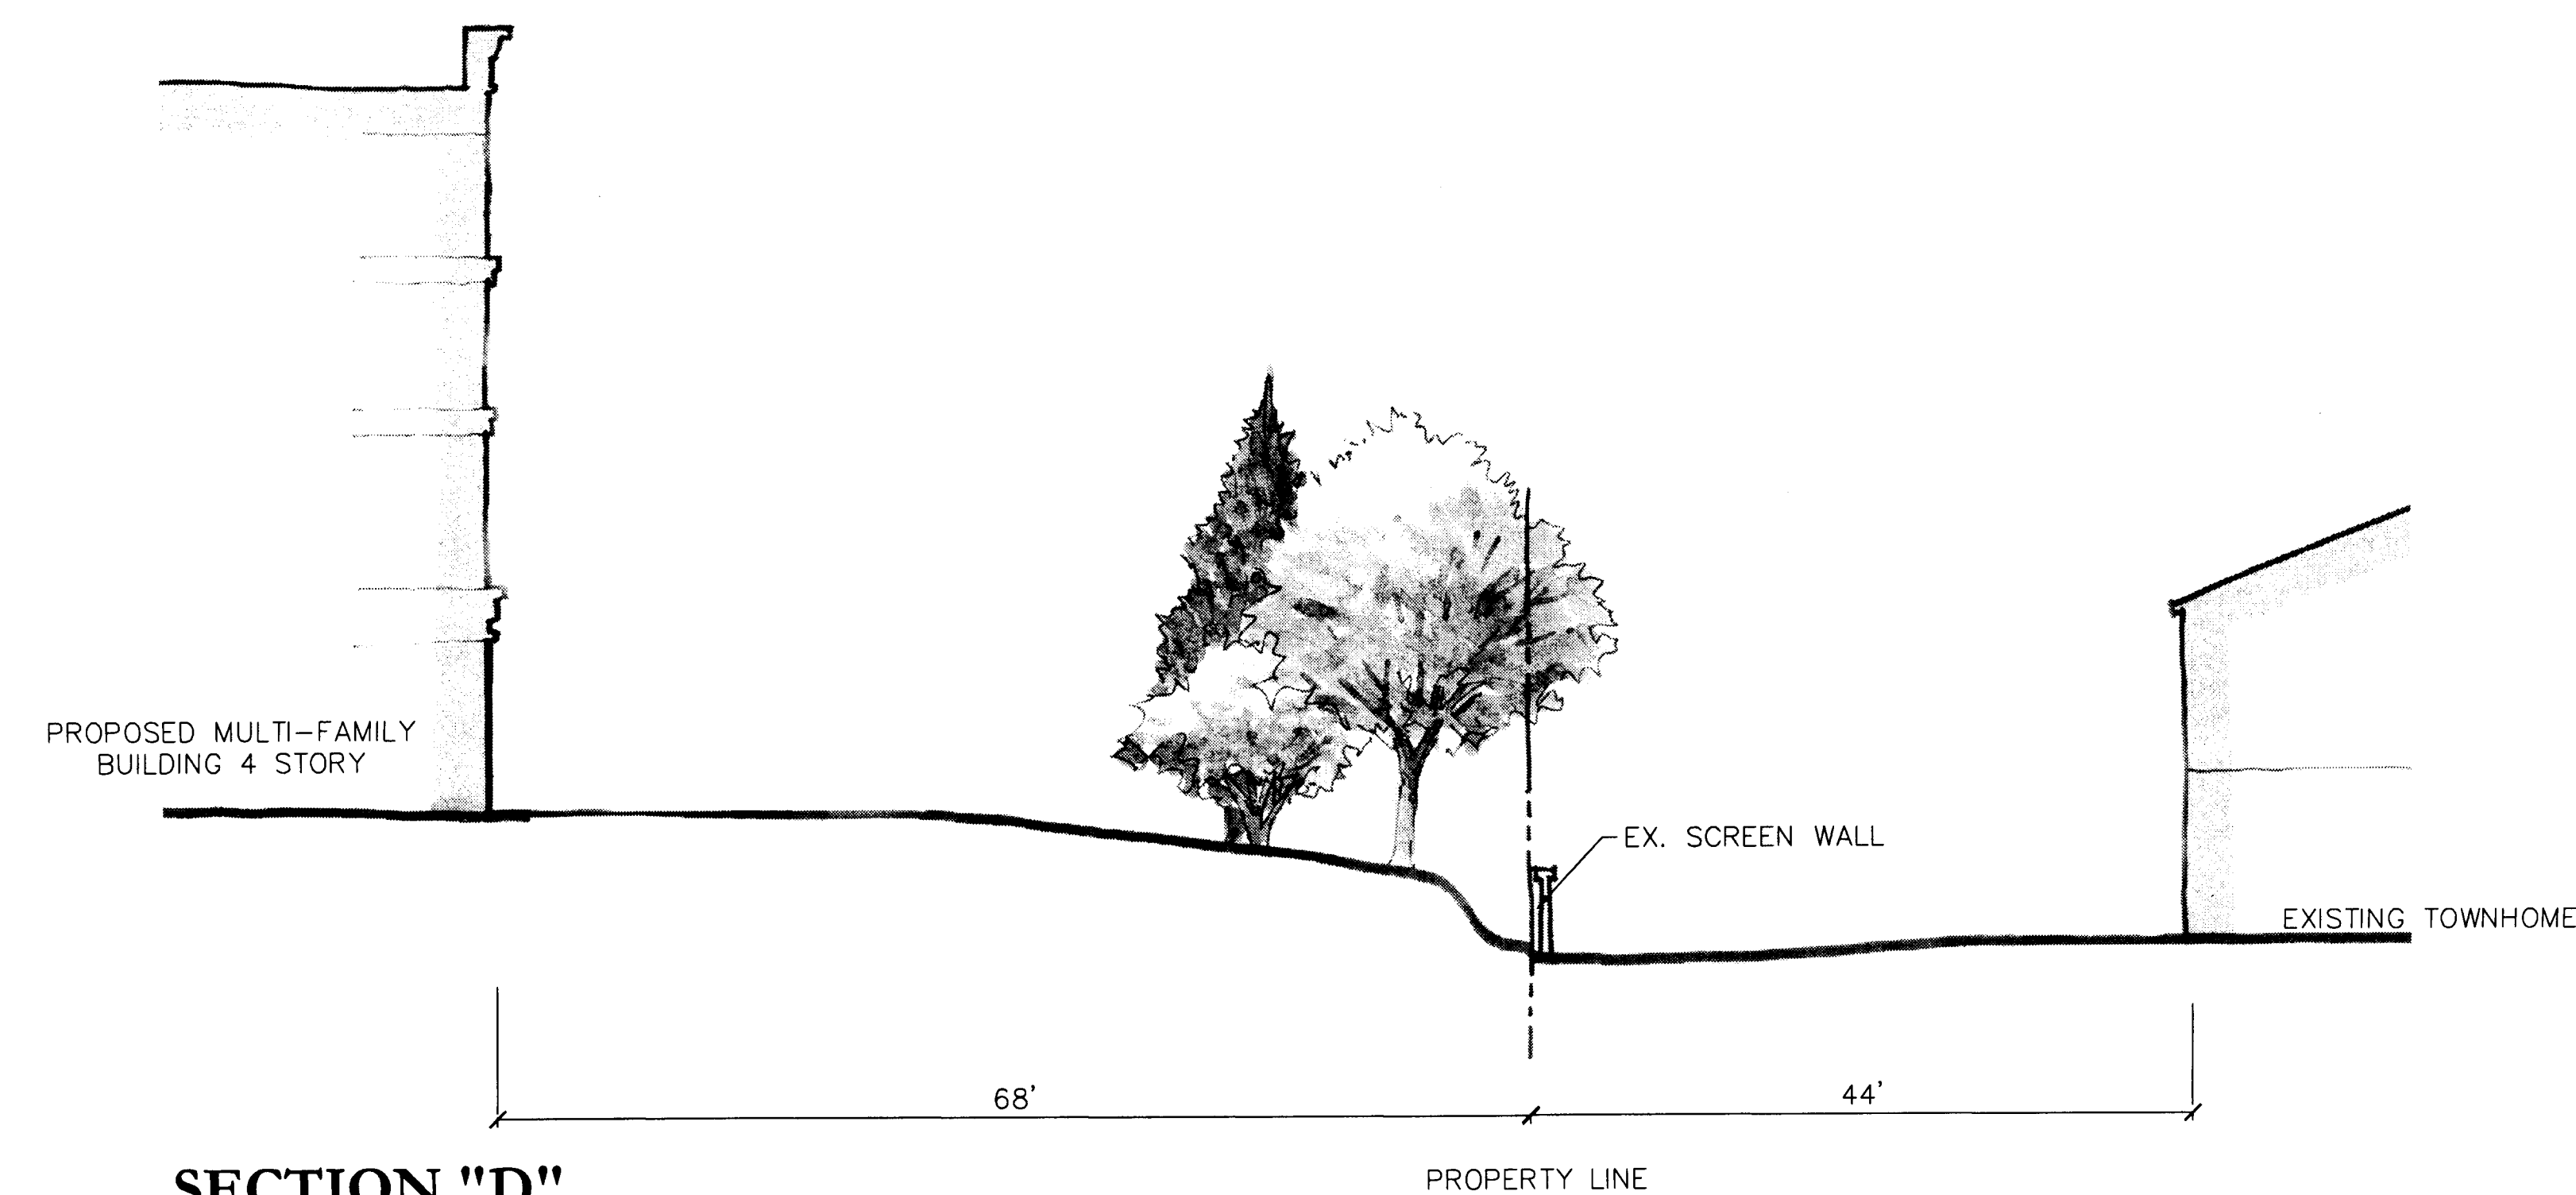

**SECTION "D"**  
1"=10'

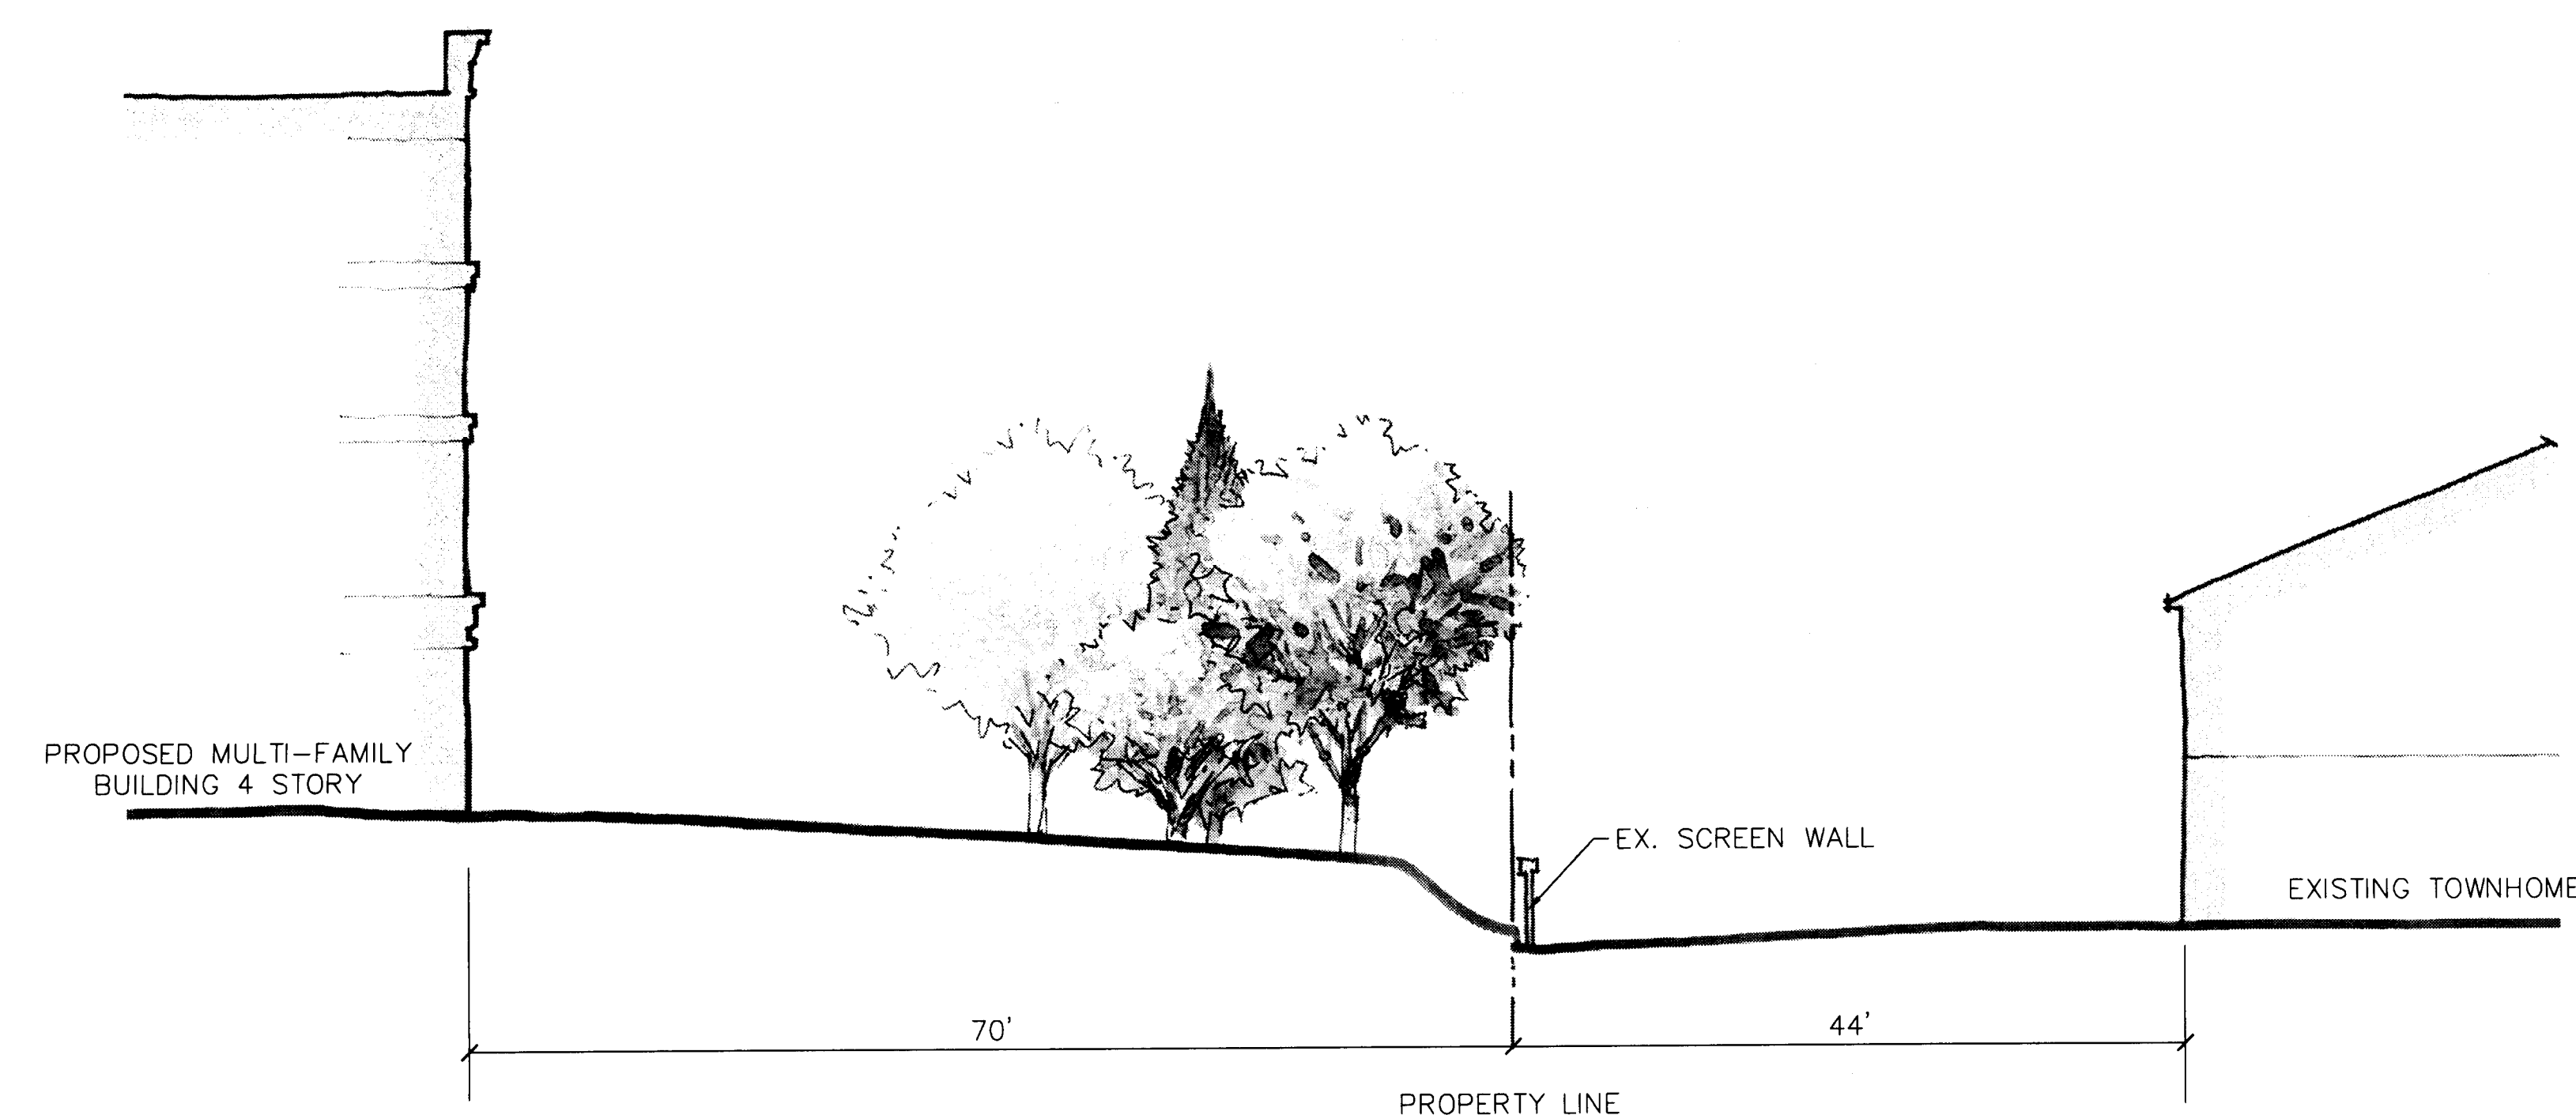


**SECTION "E"**  
1"=10'

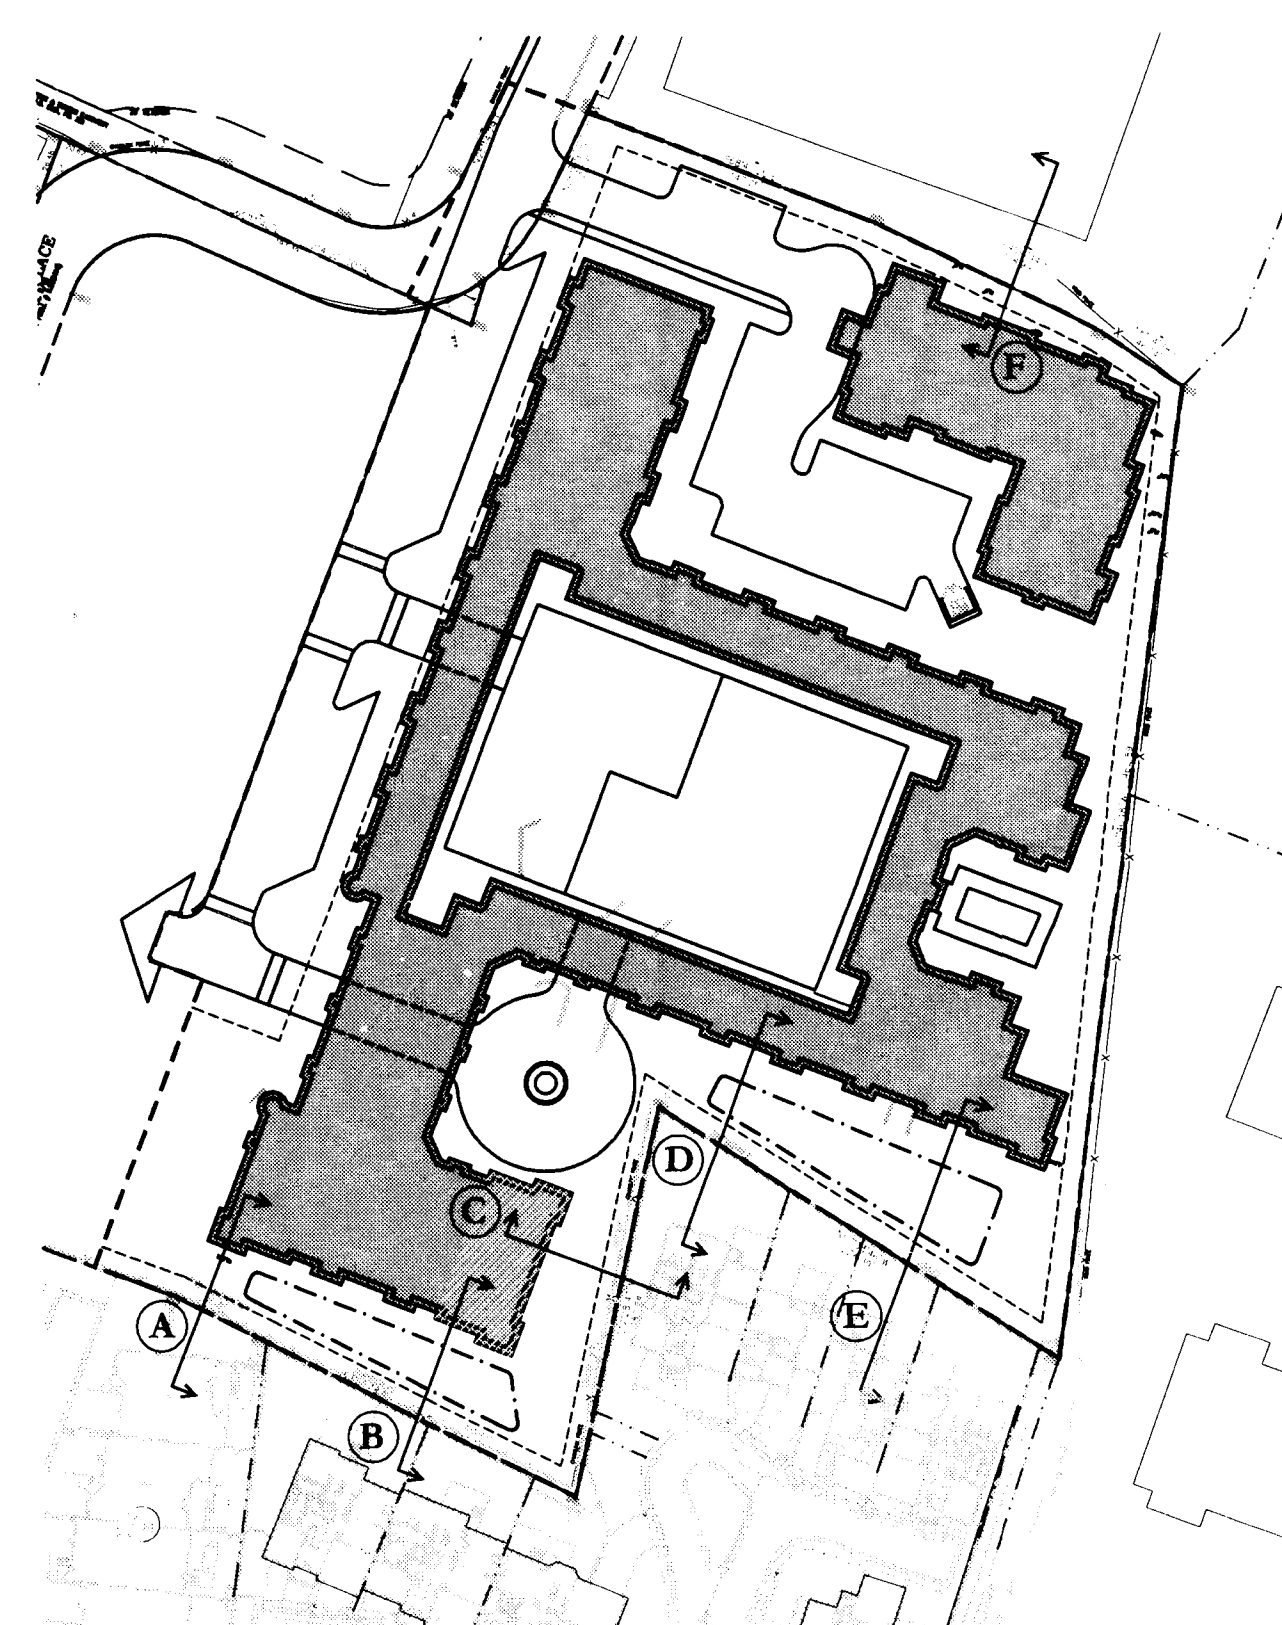





## SECTION LOCATOR MAP

**NOTE:**

THIS SHEET RZ-3 IS AN ADDITION TO THE  
ORIGINAL SUBMISSION (12-07-05).

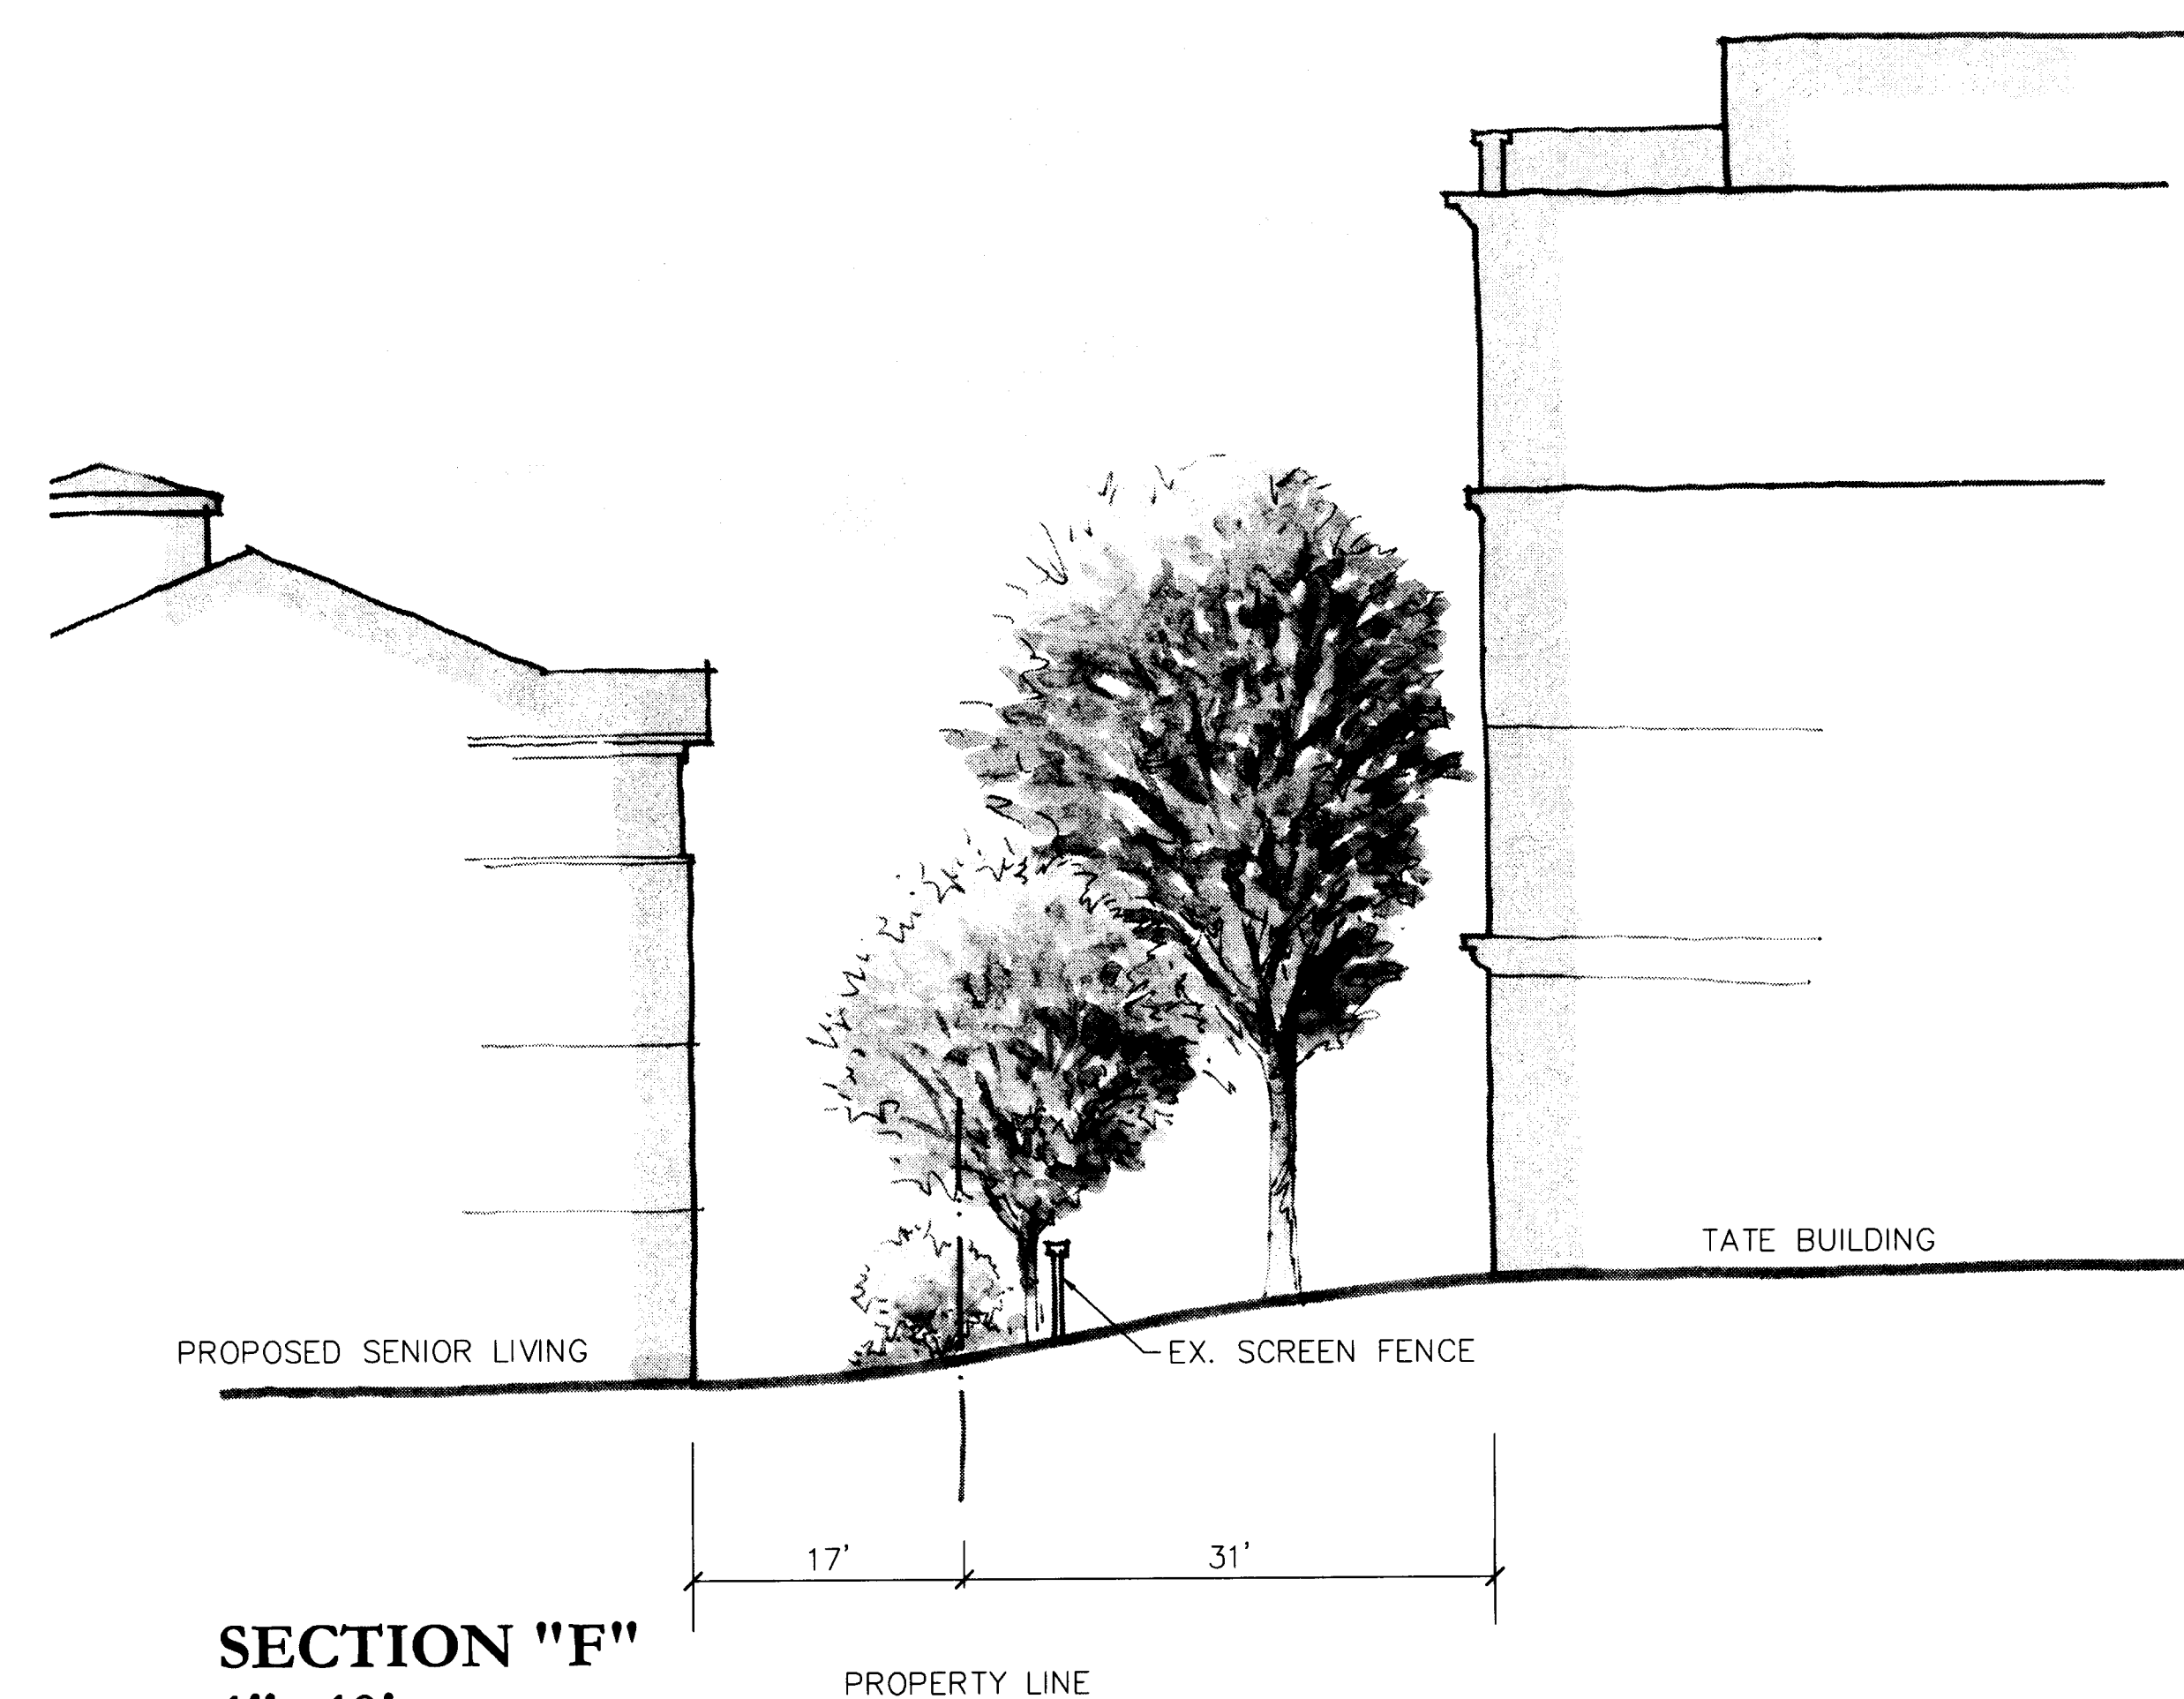

**SECTION "F"**  
**1"=10'**

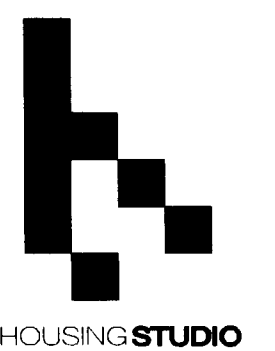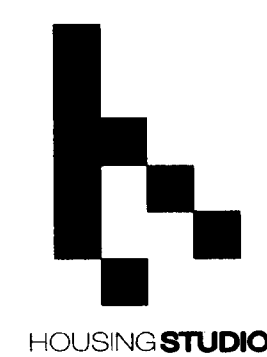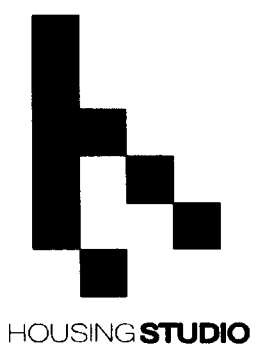 

THIS SHEET RZ-4 IS AN ADDITION TO THE ORIGINAL SUBMISSION (12-07-05).

PETITION # = 22-2006